




Elevation C

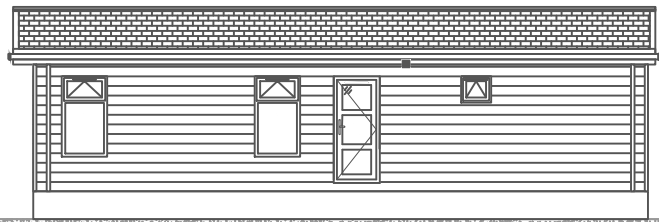

Elevation A

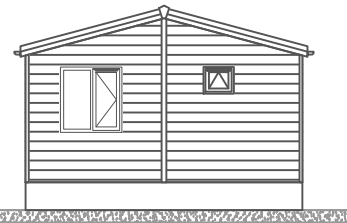

Elevation D

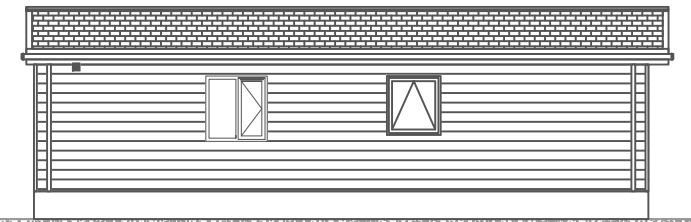


Elevation B

SALES ISSUE This copy is to review and/or amend before a technical review.

ELEVATION B

Please note that the elevations are for illustration purposes.

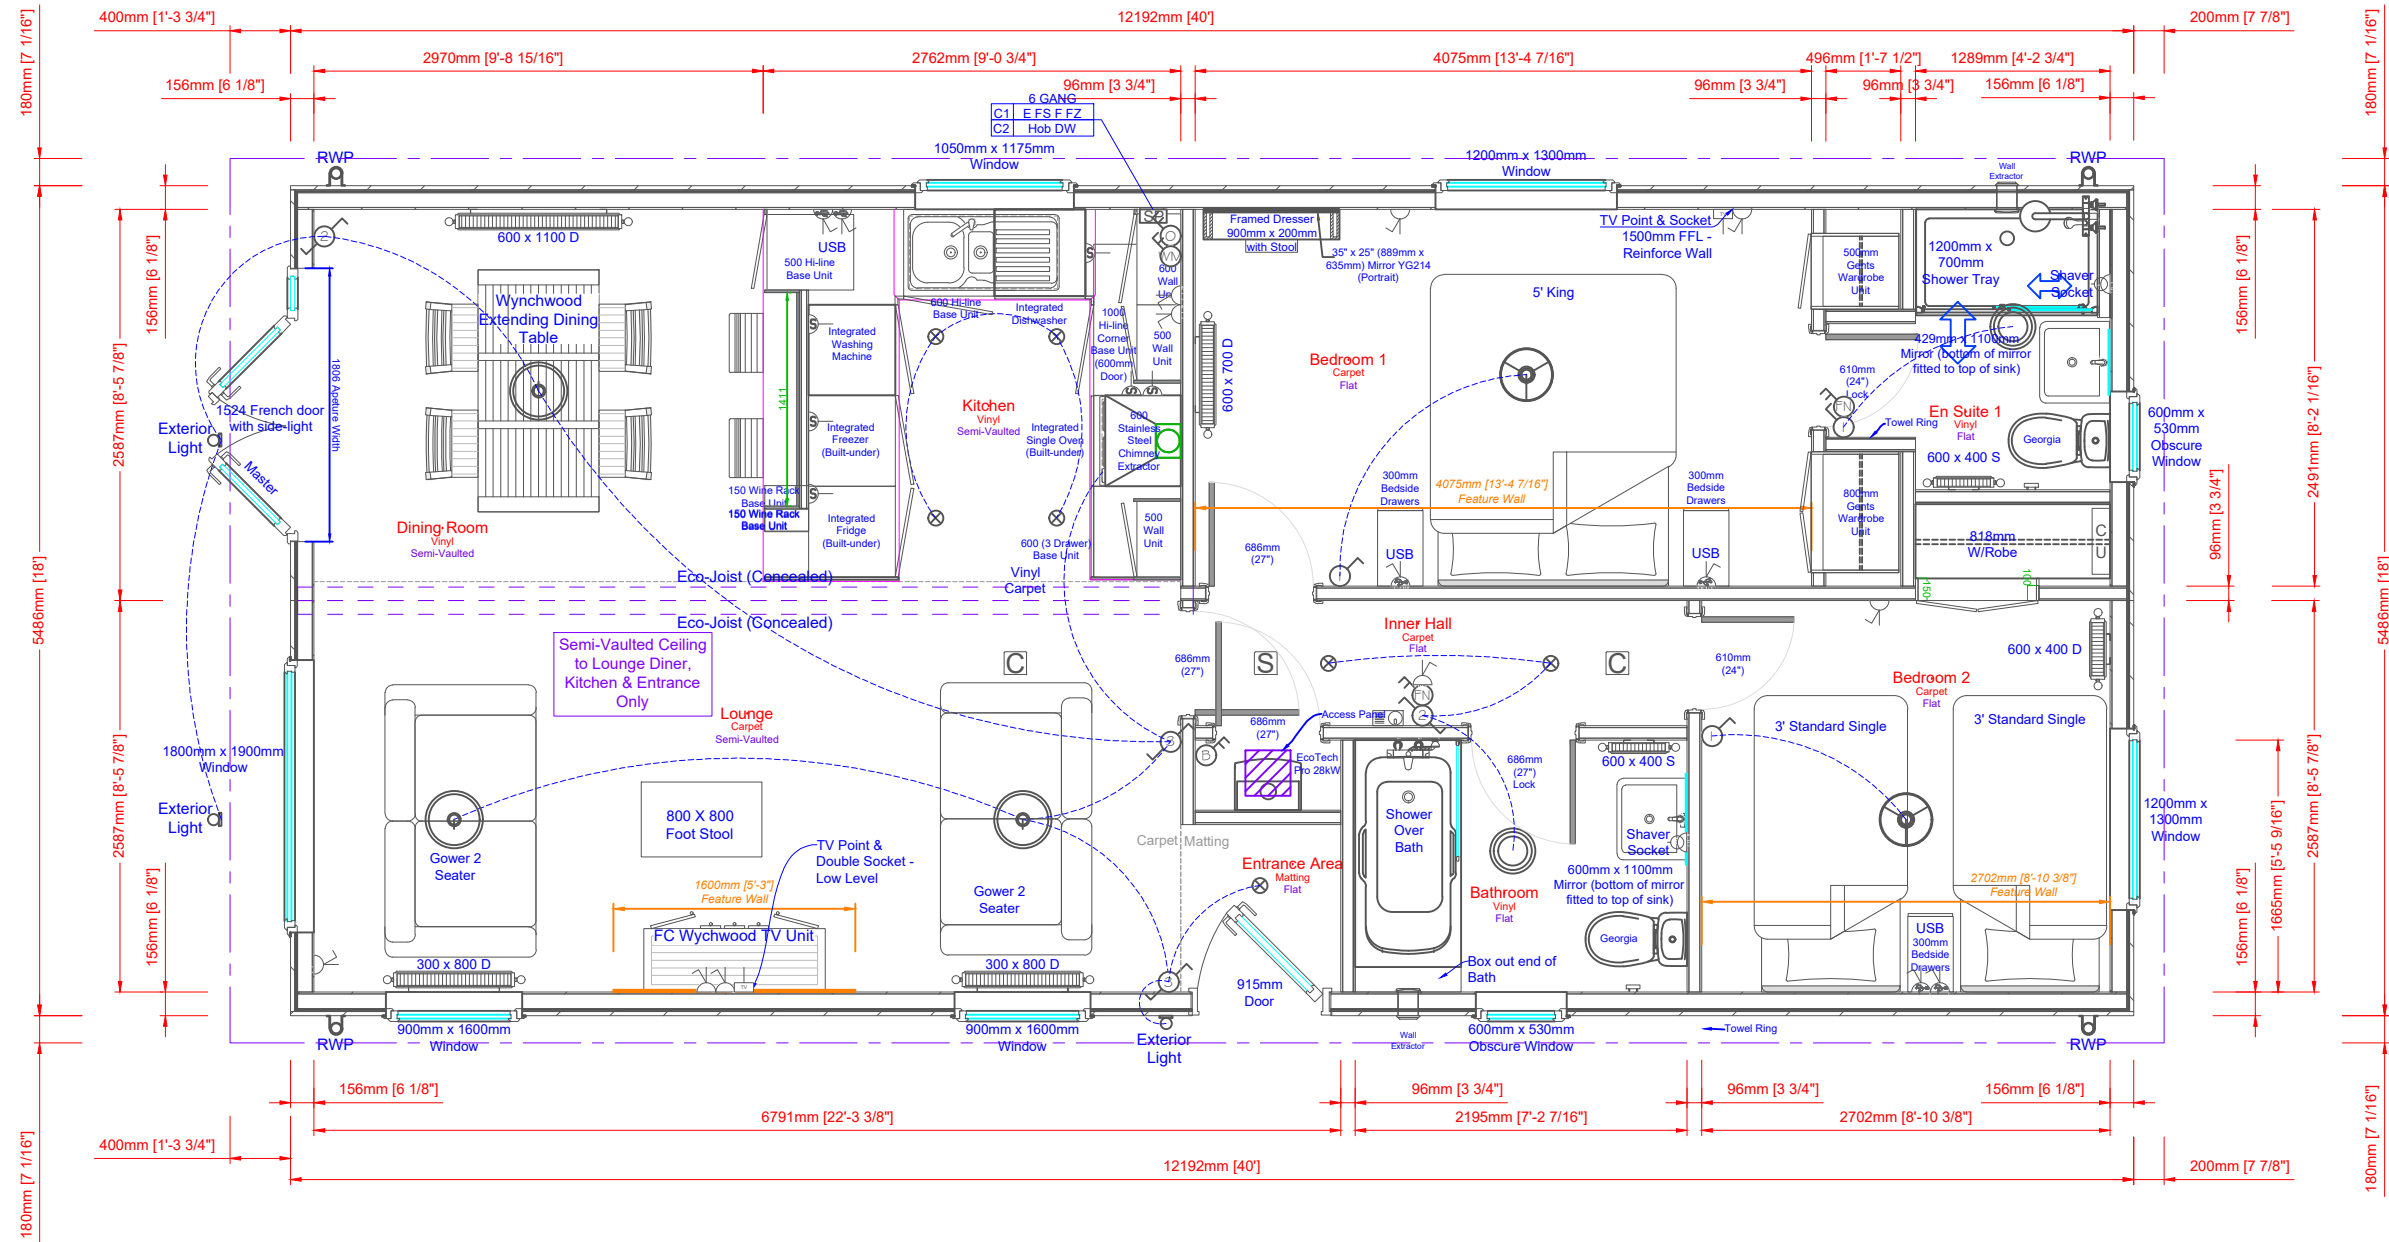

ELEVATION C

ELEVATION D

This home is designed in accordance with BS3632:2015

ELEVATION A

All measurements in mm unless stated otherwise.



A Shipton Way, Express Business Park, Rushden, Northamptonshire, NN10 6GL.
T (01933) 354000
E sales@phph.com
W prestigehomeseeker.com
C Copyright © Prestige Homeseeker

LEGEND table with symbols for electrical and plumbing fixtures: Sockets, Thermostat, Switches/Isolators, Smoke Alarm, CO Alarm, Consumer Unit, Under Locker Light, Downlight, Batten Holder, Ceiling Rose.

NOTES table with a single entry: N/A

REVISION HISTORY table with columns for Date, Description, and Author. Entry: Or. 30/09/20 PR Original

DRAWING table with columns for Scale, Quote, Drawing, Int. Serial, Ext. Serial, Class, and Drawn By. Entry: Scale: Relative, Quote: QN 40073, Drawing: S7330, Int. Serial: J????, Ext. Serial: 19 ?? 00????, Class: SP1, Drawn By: PR

Plantation House 40' x 18'
2 Bed (DB TB) ES
12.19m x 5.49m Nominal
McFarlands - Brickhill Park
Signature: X
Date: / /